


Fire Alarm Company
Physical Address
City, State Zip

No#	Revision Description	Date
1	Technology Plan As Built	10/26/10

Business Name Here
Physical Address
City, State Zip

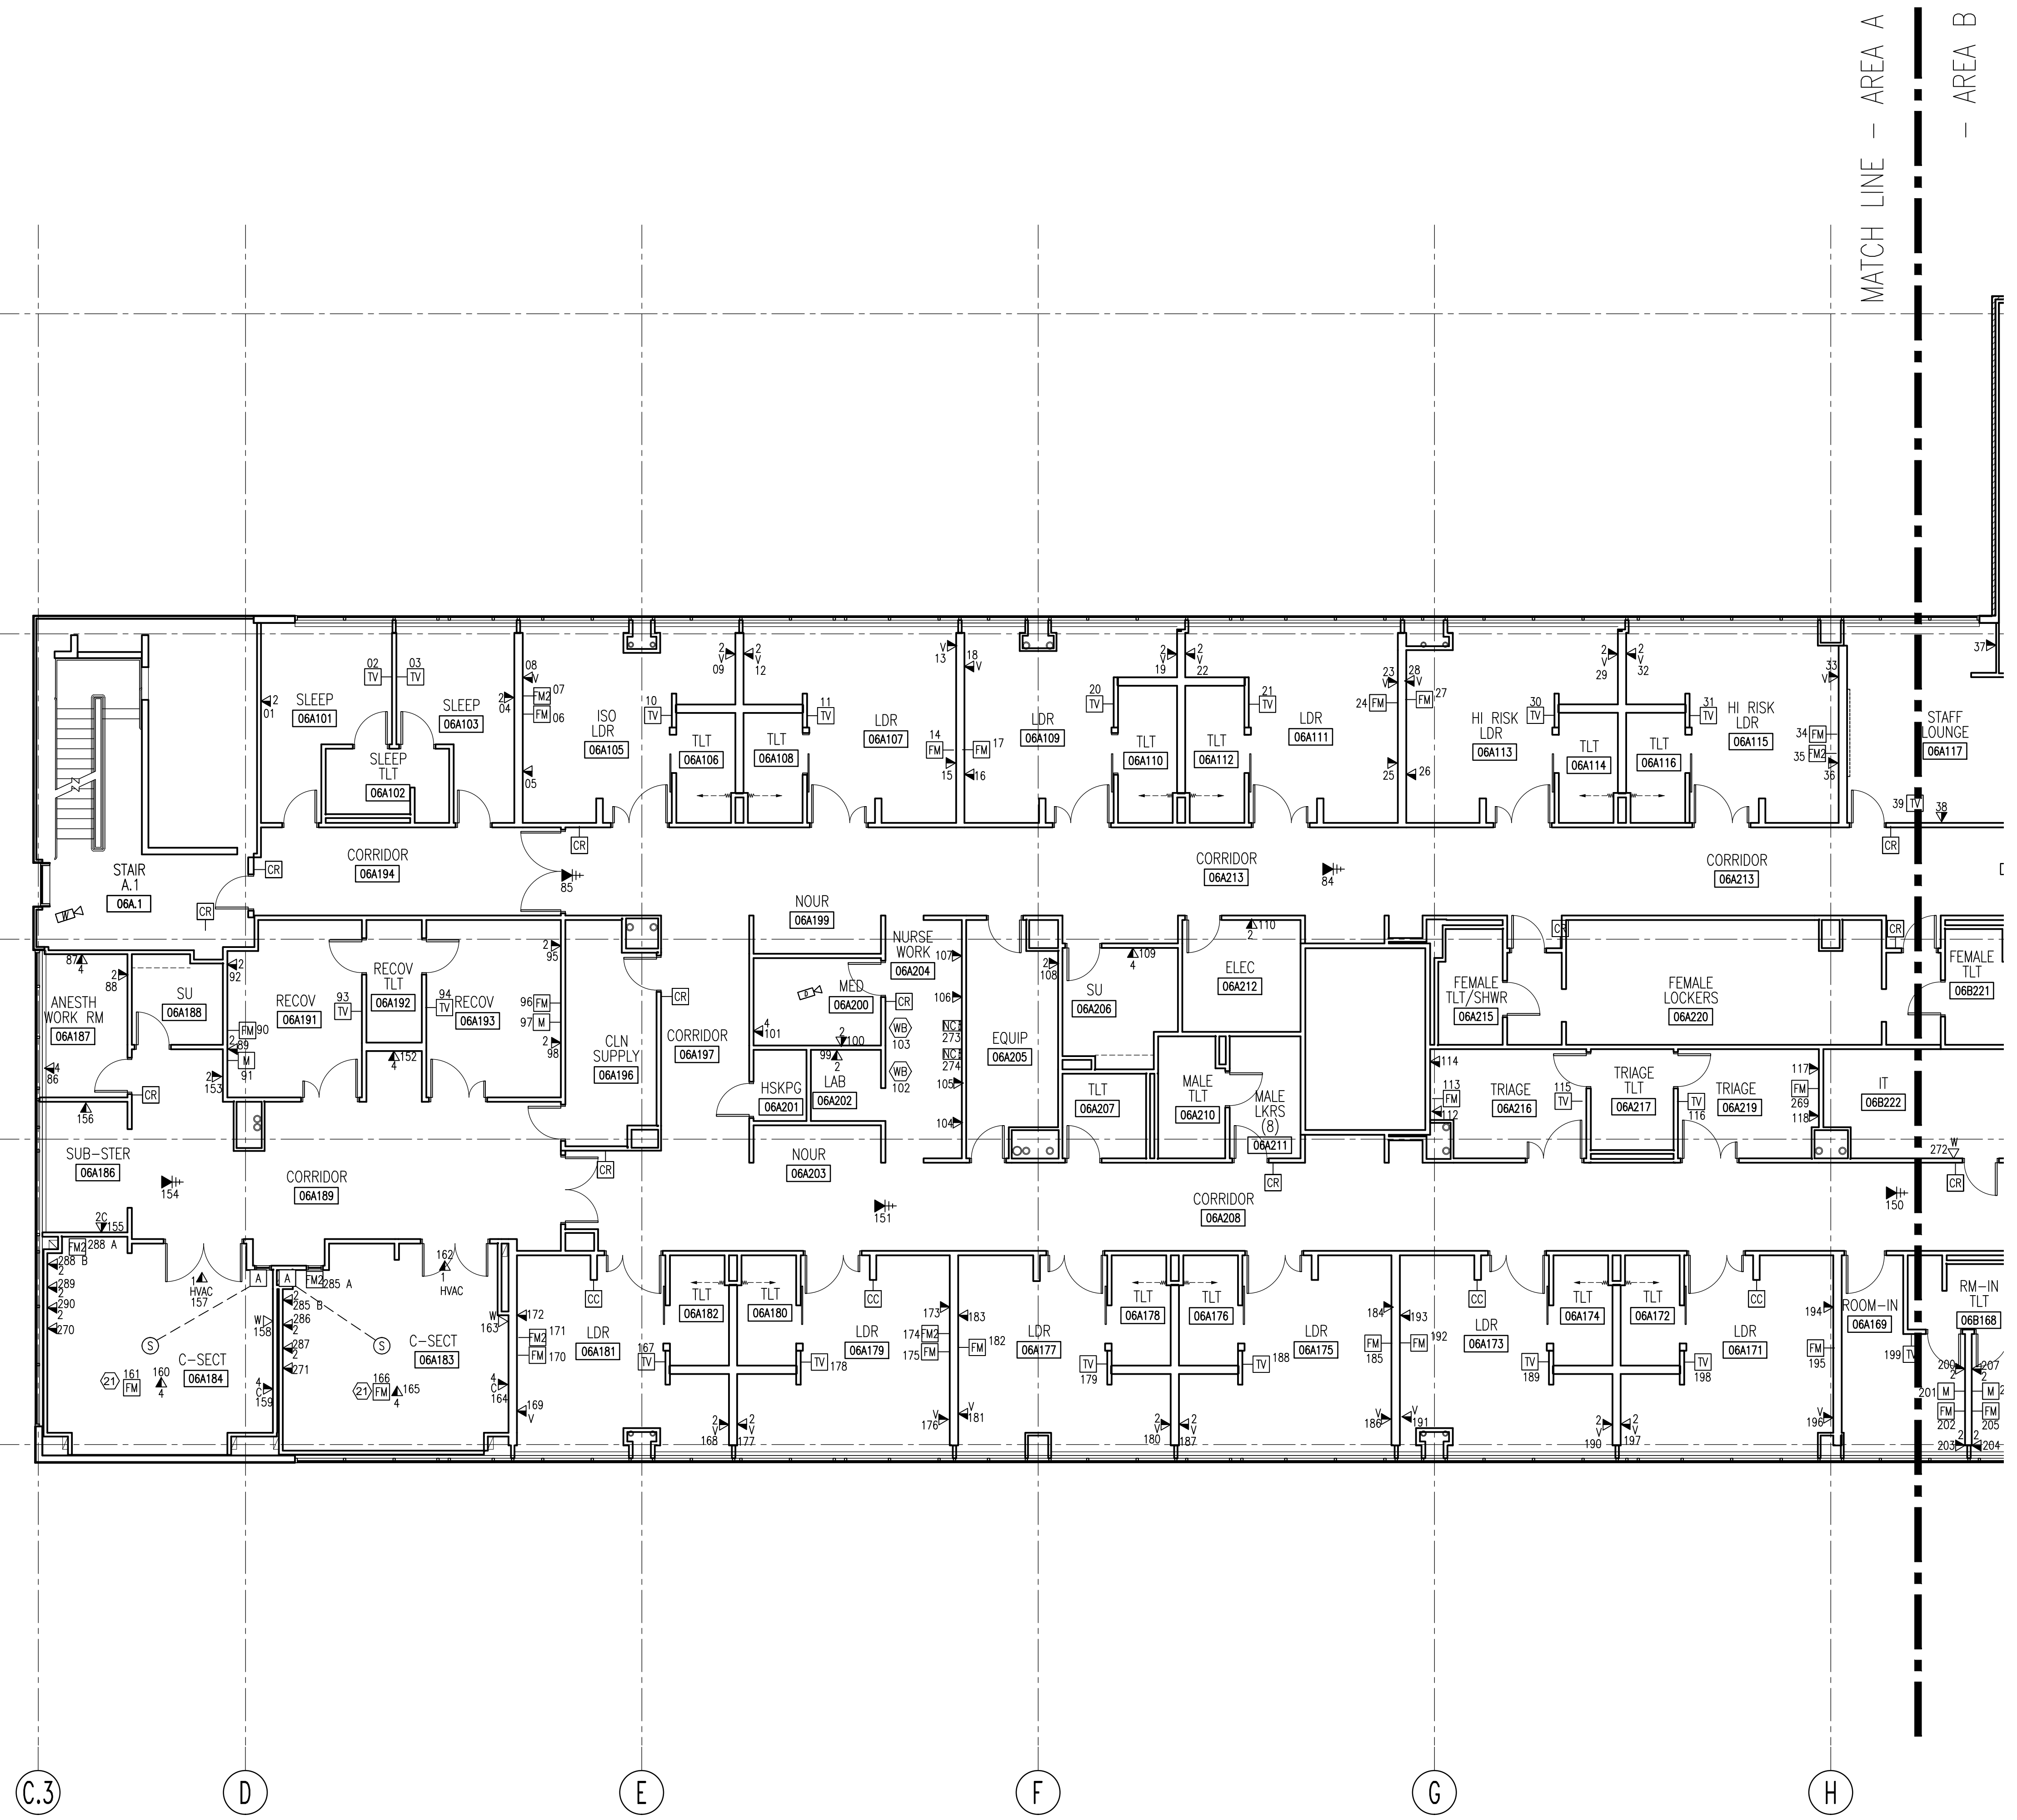

1 SIXTH FLOOR TECHNOLOGY PLAN - AREA A
1/8"=1'-0"

IMM
INTERMOUNTAIN MARKETING INC.
Representing The Manufacturer
CAD Solutions
455 Kokopelli Blvd, Suite D
Fruita, CO 81521
Telephone: (970) 639-8035
www.immep.com


Sheet Information	
Date	
Job Number	51009.003
Drawn	
Checked	
Approved	
Title	

6TH FLOOR
TECHNOLOGY PLAN
- AREA A

Sheet

T-306-A

No#	Revision Description	Date
1	Technology Plan As Builts	10/26/10

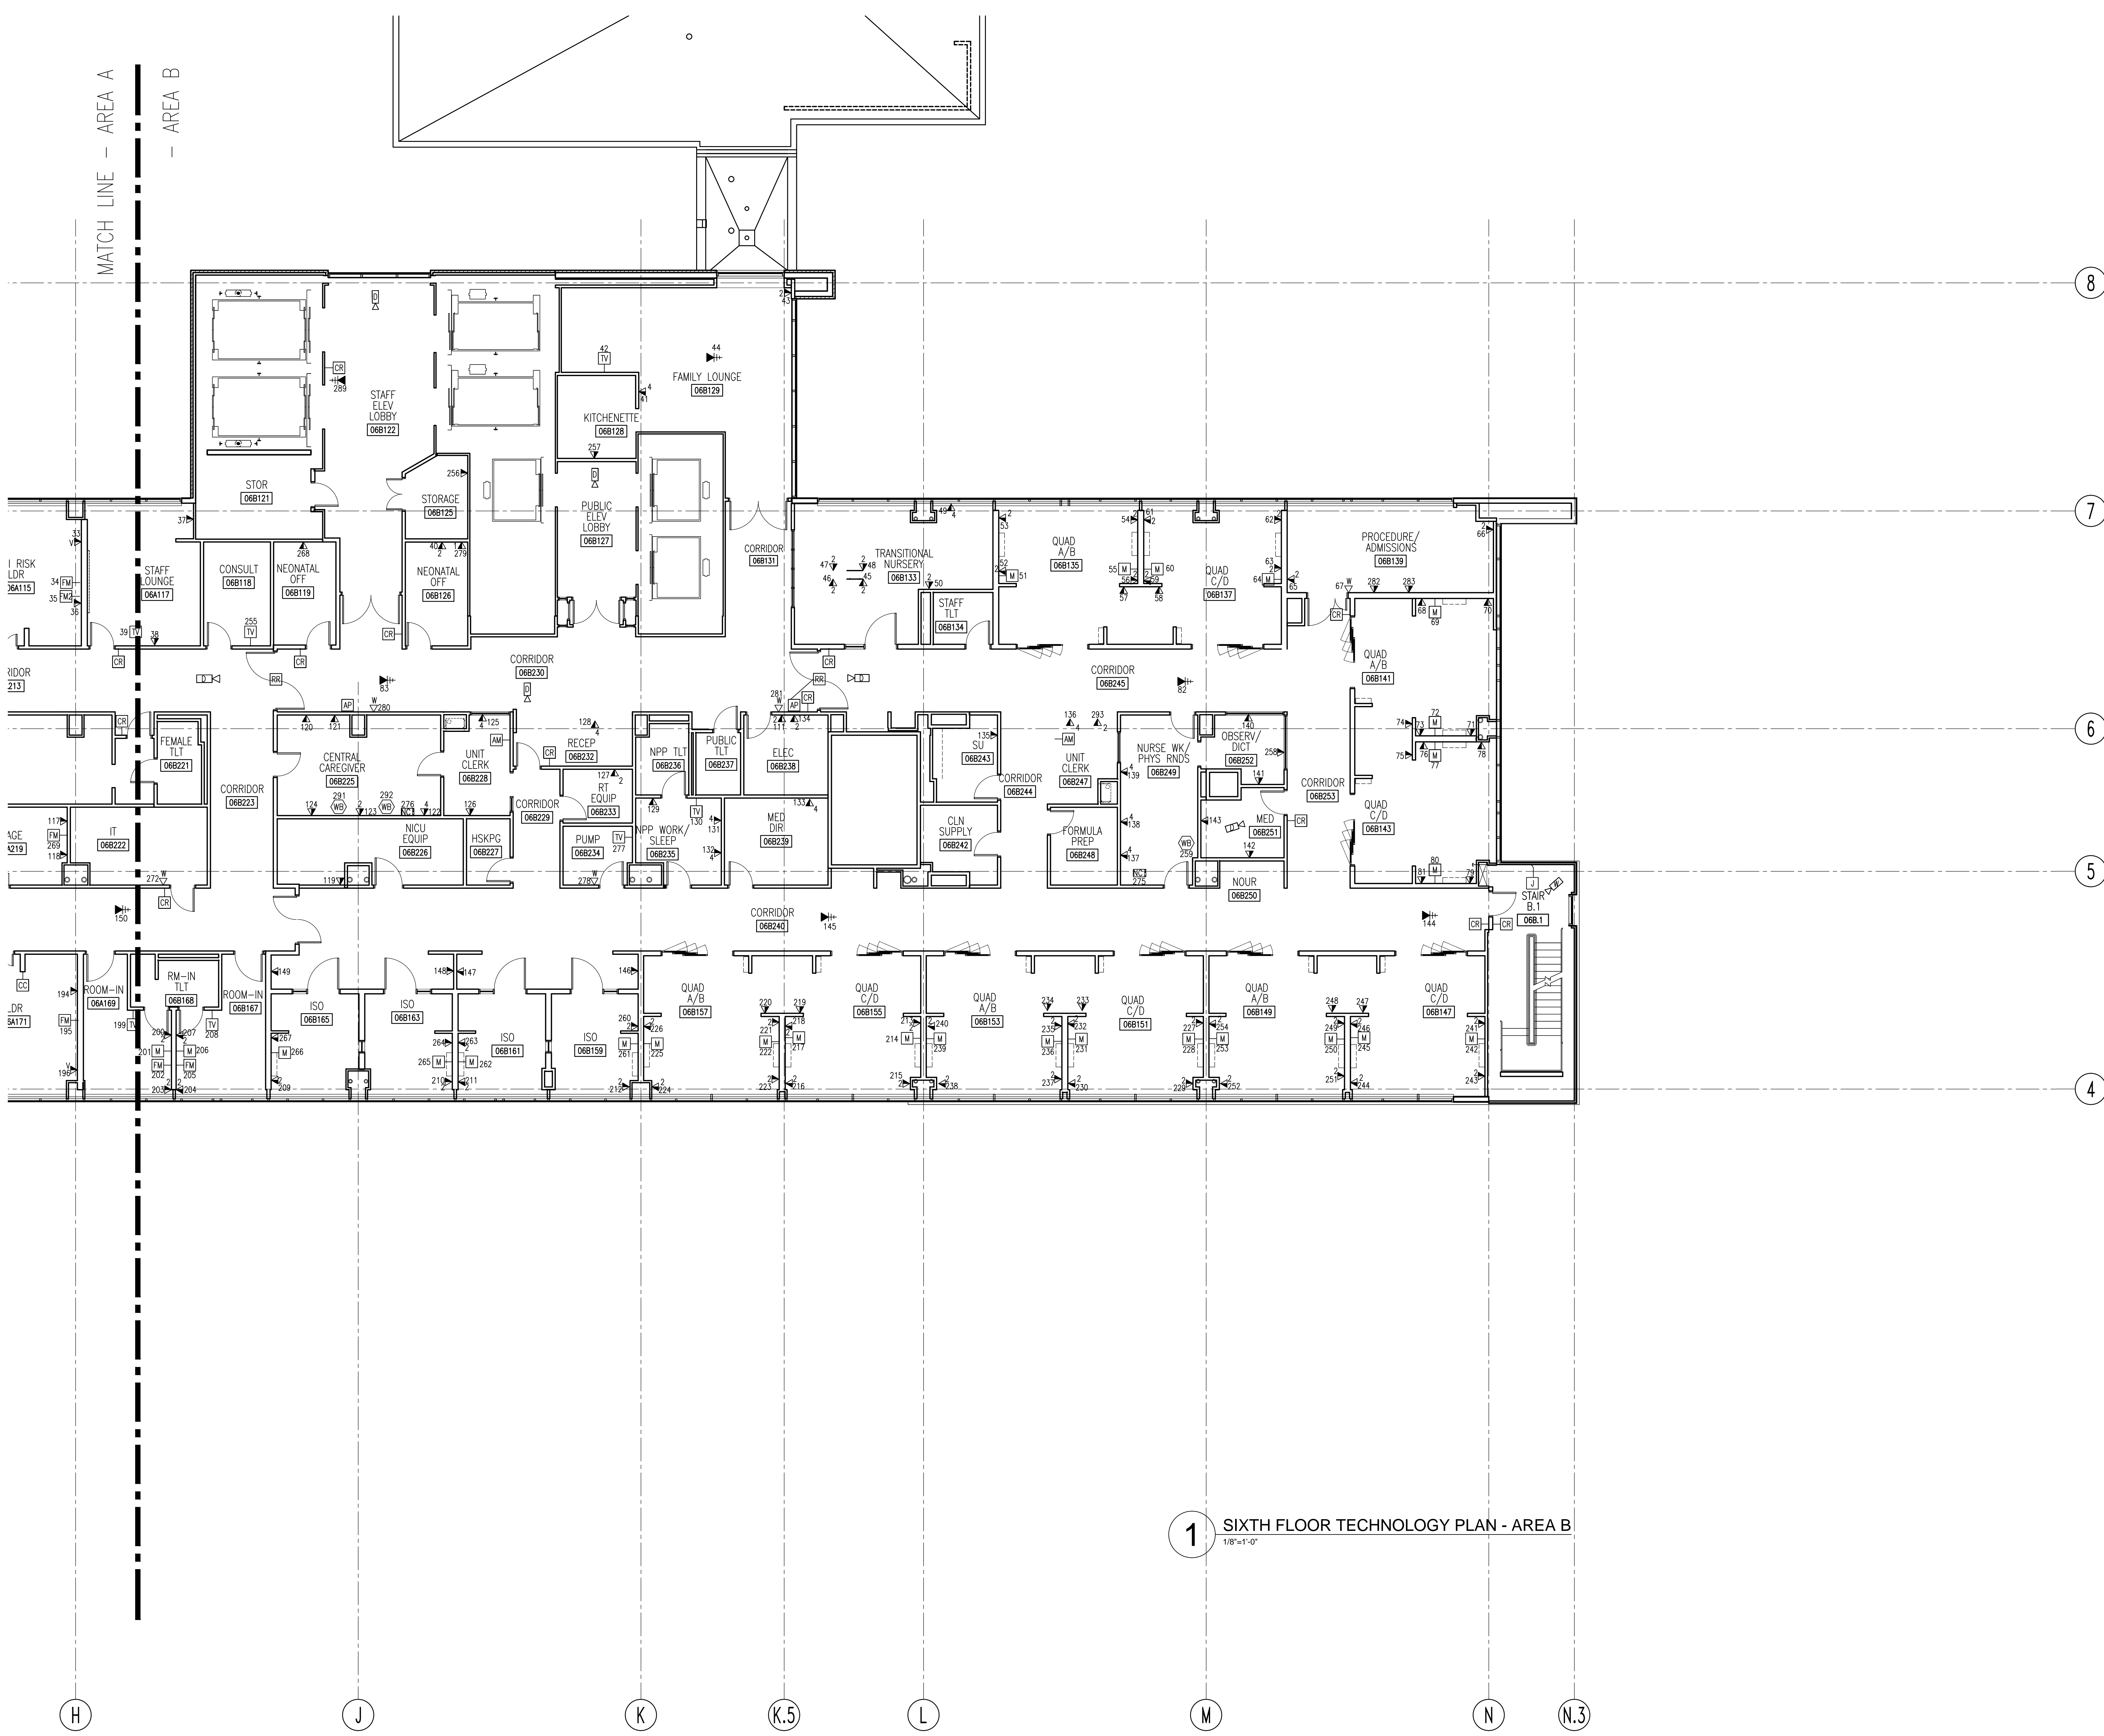

Business Name Here
Physical Address
City, State Zip

1 SIXTH FLOOR TECHNOLOGY PLAN - AREA B
1/8"=1'-0"

IMM
INTERMOUNTAIN MARKETING INC.
Representing The Manufacturer
CAD Solutions
455 Kokopelli Blvd, Suite D
Fruita, CO 81521
Telephone: (970) 639-8035
www.IMMrep.com

Sheet Information	
Date	02.22.10
Job Number	51009.003
Drawn	
Checked	
Approved	
Title	

6TH FLOOR
TECHNOLOGY PLAN
AREA B

Sheet

T-306-B