

Company Name Here

Physical Address  
City, State, Zip

**BUSINESS NAME  
FIRE ALARM SUBMITTAL**

PHYSICAL ADDRESS  
CITY, STATE, ZIP  
MAIN BUILDING SQUARE FOOTAGE: 50,000  
OCCUPANCY CLASSIFICATION: CLASS B




**N** SITE PLAN  
SCALE: NONE


Company Name  
Physical Address  
City, State, Zip

No#	Revision Description	Date
1	Fire Alarm System Submittal	11/11/10
x		
x		
x		

Business Name  
Physical Address  
City, State, Zip

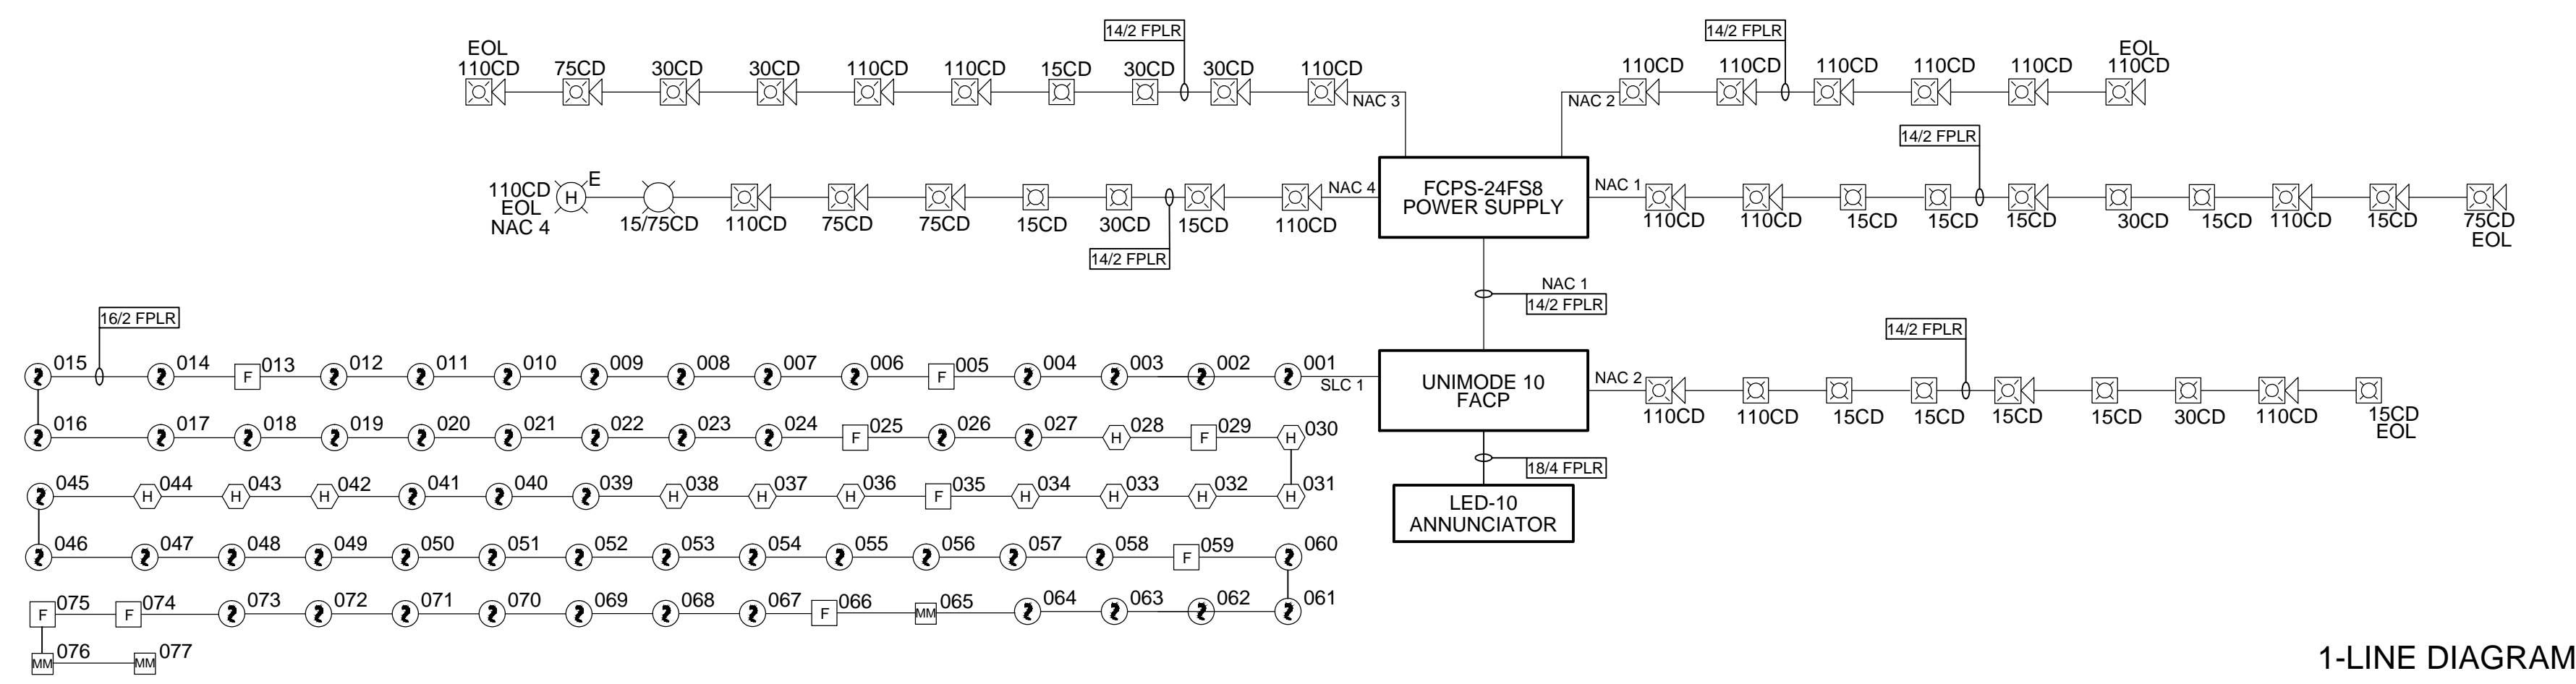

1-LINE DIAGRAM

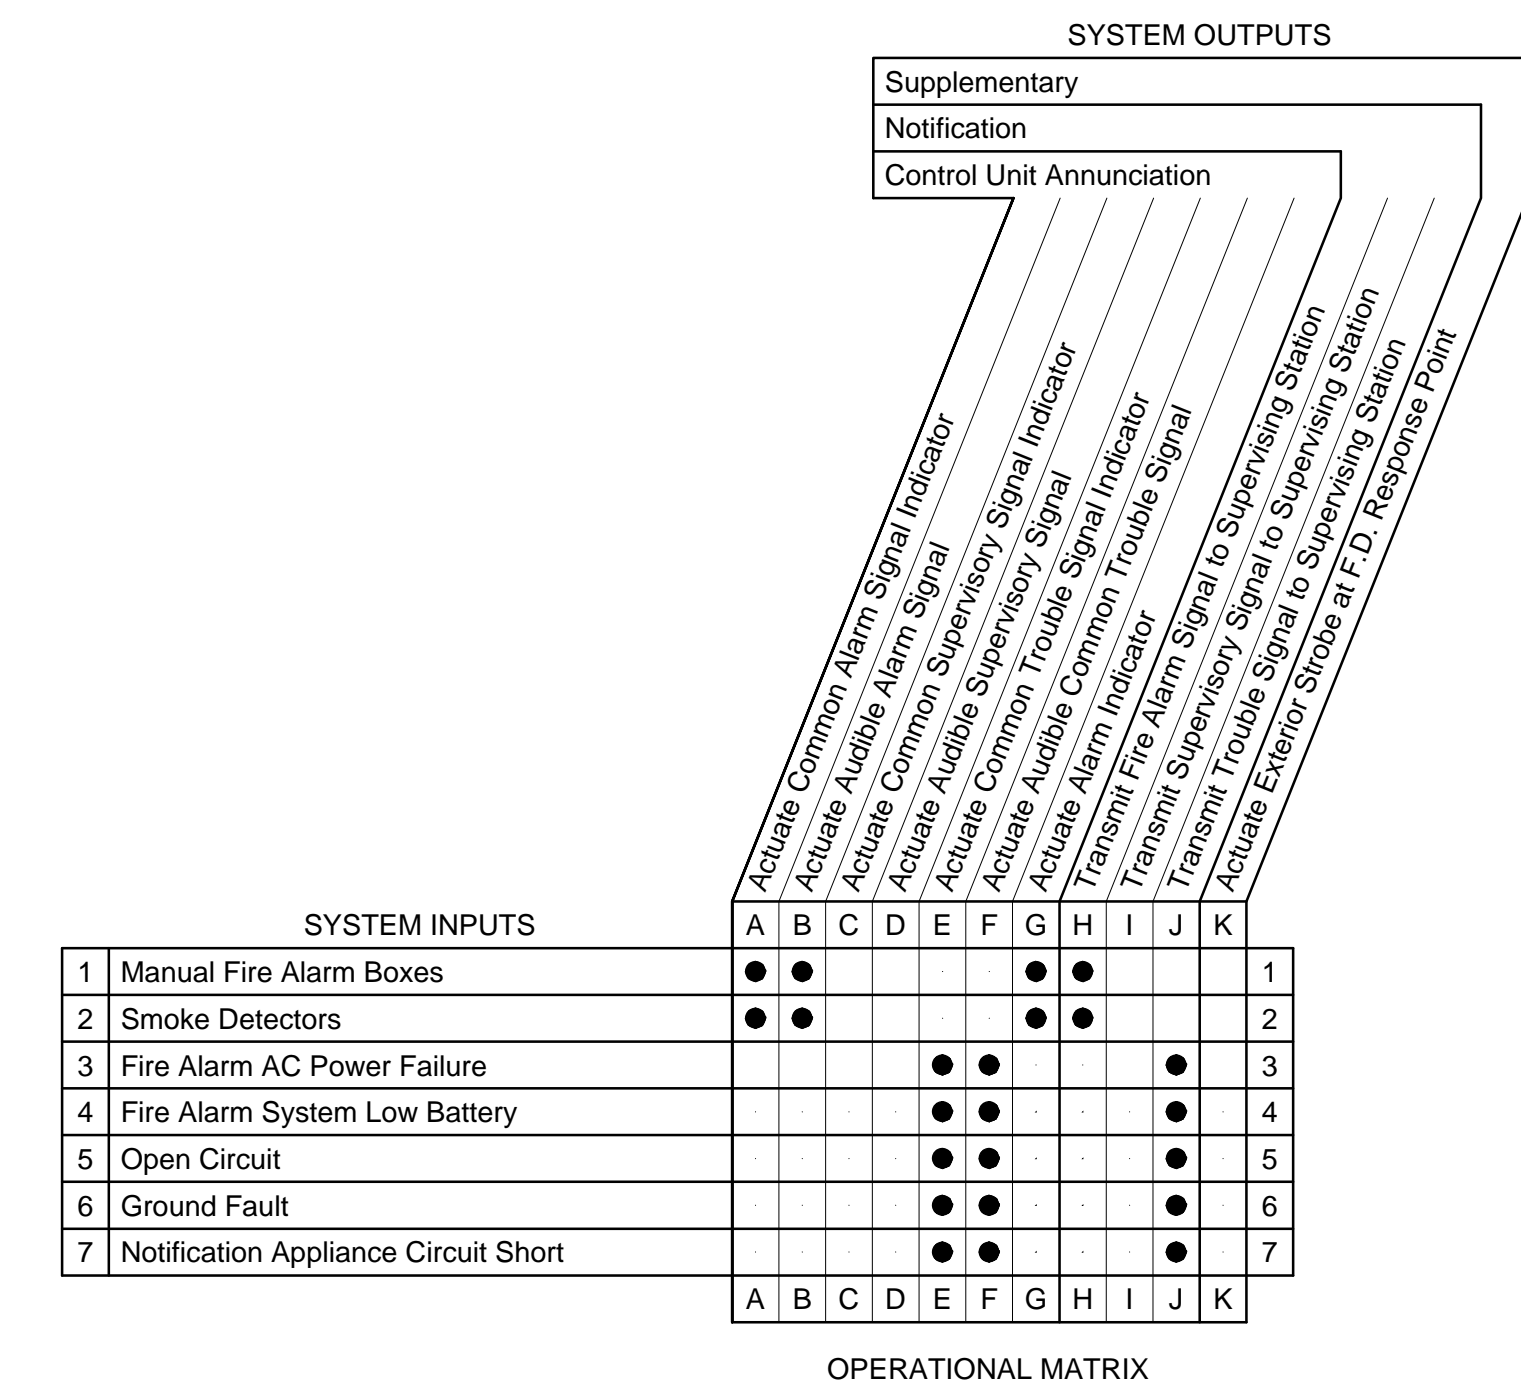


OPERATIONAL MATRIX

**IMM**  
INTERMOUNTAIN MARKETING INC.  
*Representing The Manufacturer*  
CAD Solutions  
455 Kokopelli Blvd, Suite D  
Fruita, CO 81521  
Telephone: (970) 639-8035  
www.IMMrep.com

ENGRD BY:  
DRAWN BY: VJH  
SCALE: 1/8" = 1'-0"  
JOB NUMBER:  
PLOT DATE: 11/11/2010  
FILENAME:

**COVER**

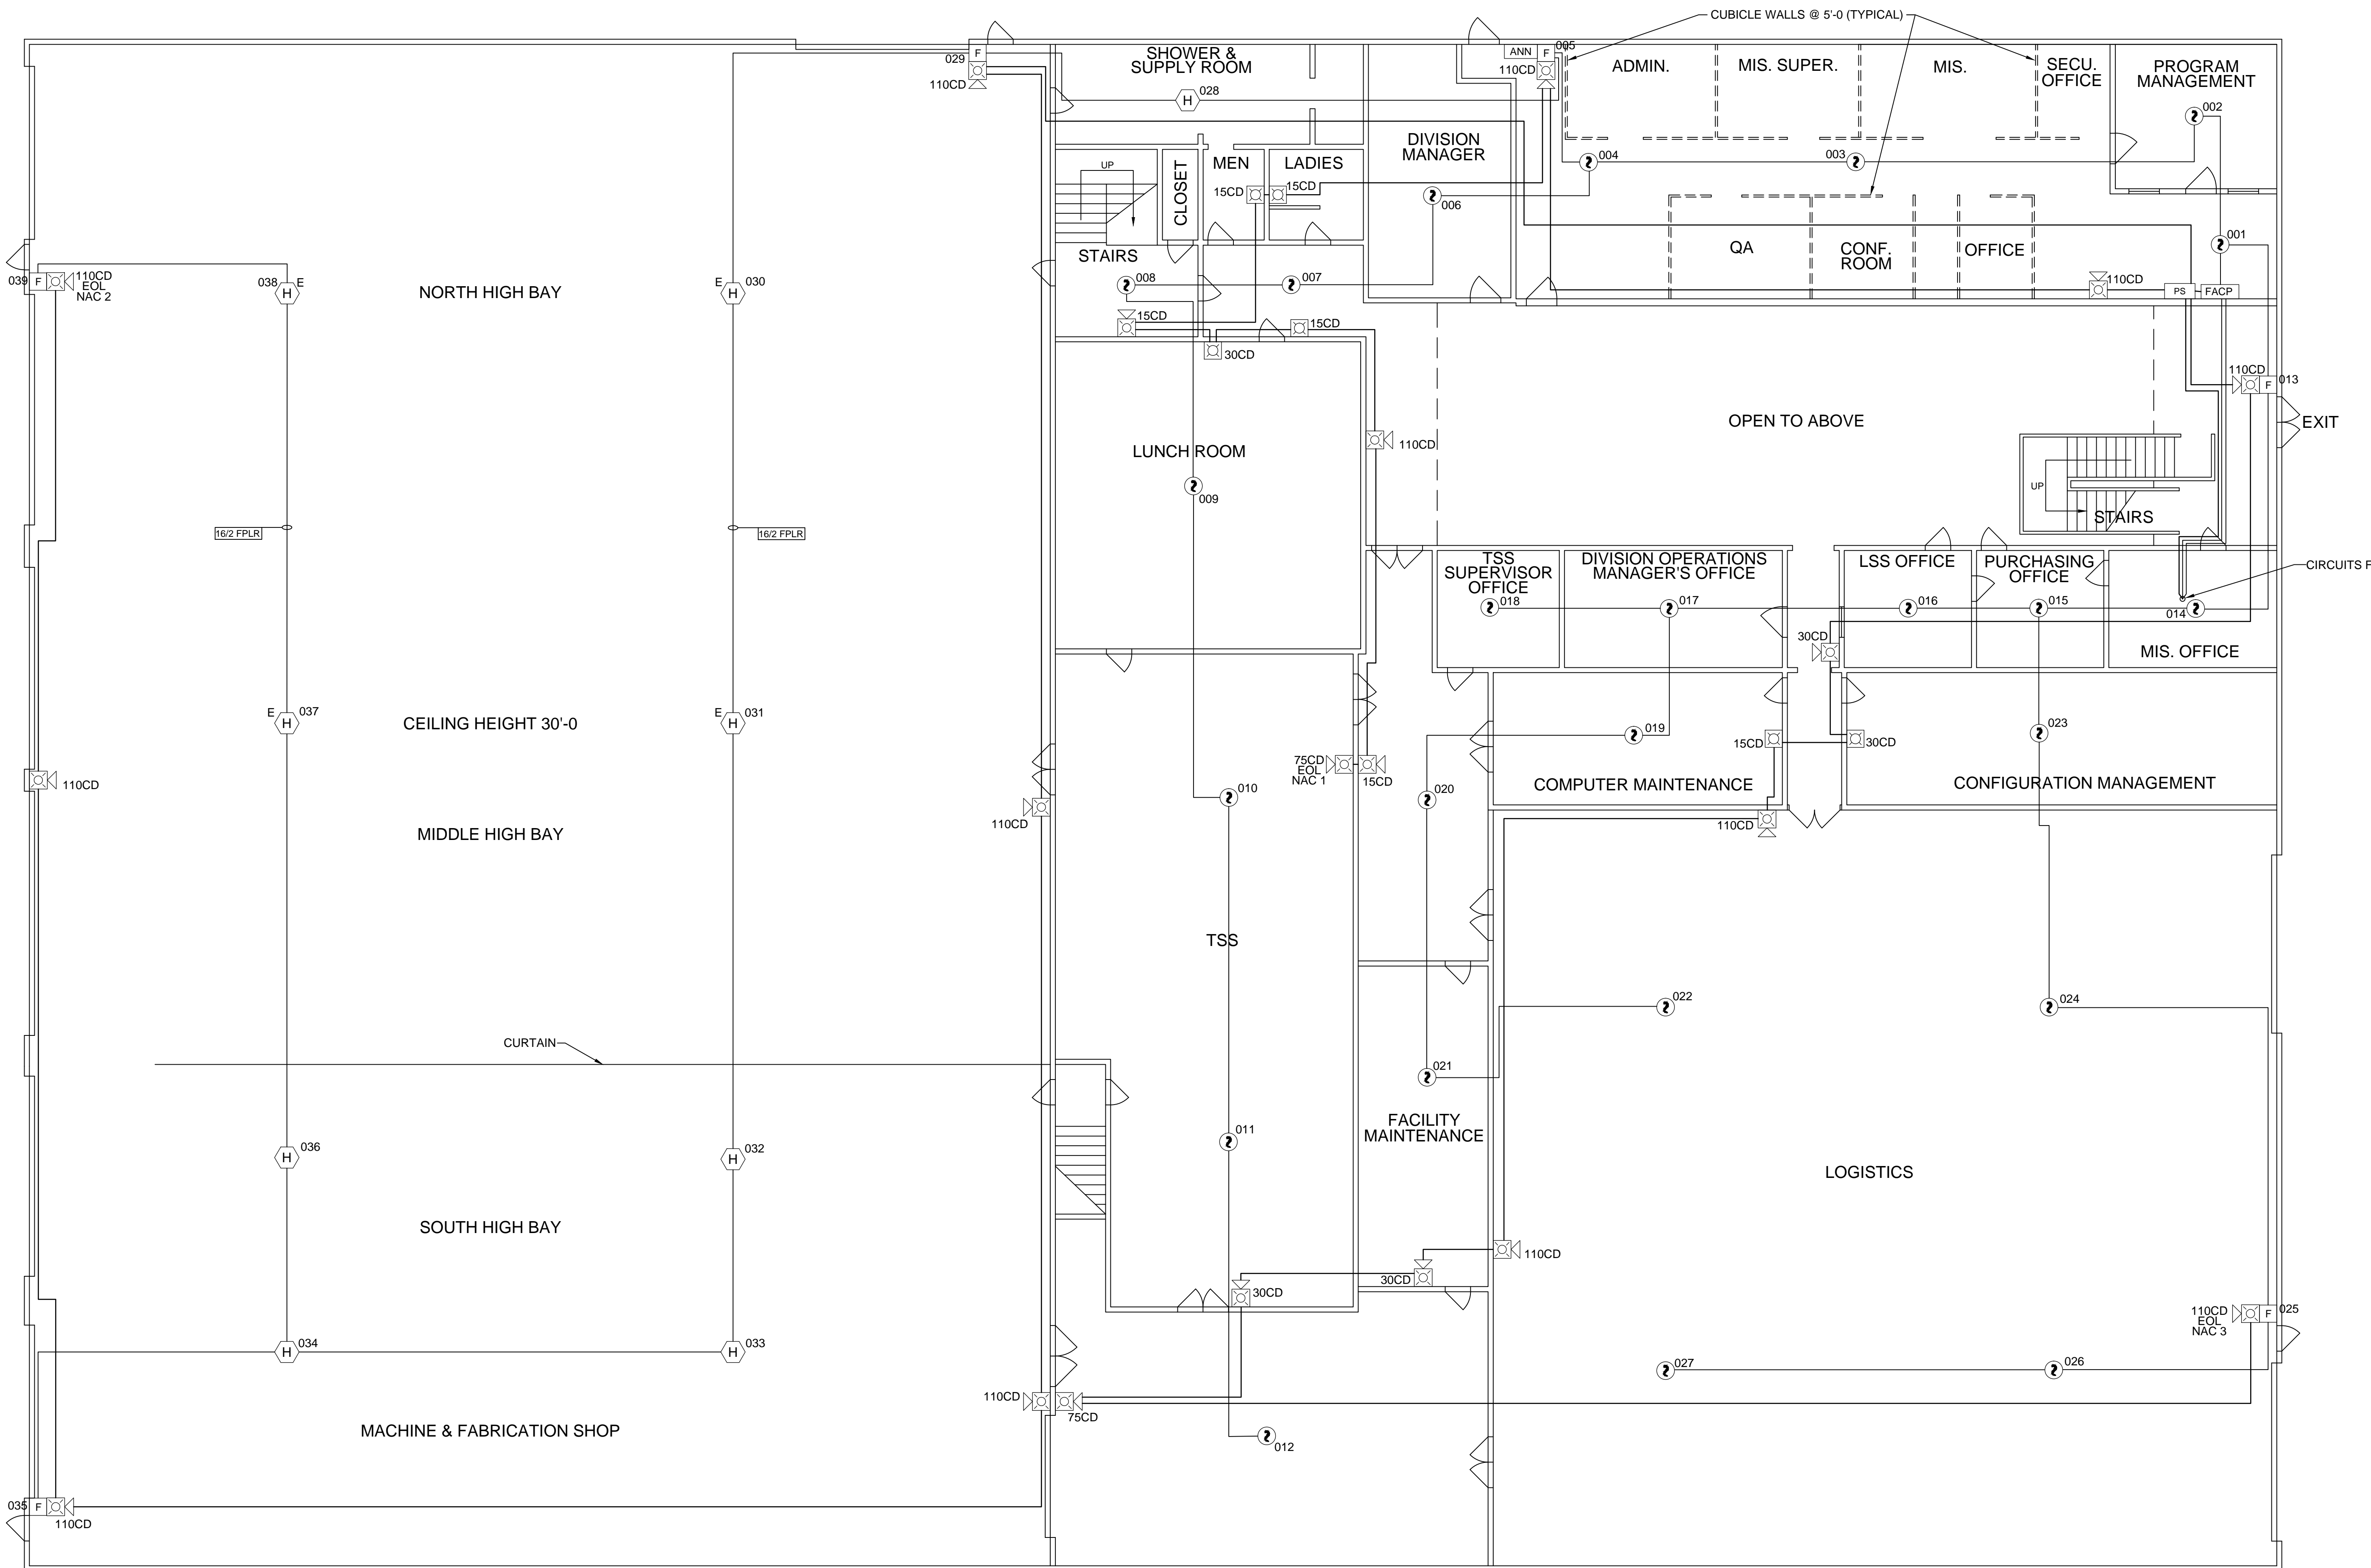

Company Name  
Physical Address  
City, State, Zip

No#	Revision Description	Date
1	Fire Alarm System Submittal	11/9/10
x		
x		
x		

Business Name  
Physical Address  
City, State, Zip


**IMM**  
INTERMOUNTAIN MARKETING INC.  
*Representing The Manufacturer*

CAD Solutions  
455 Kokopelli Blvd, Suite D  
Fruita, CO 81521  
Telephone: (970) 639-8035  
www.IMMrep.com

ENGRD BY:  
DRAWN BY: VJH  
SCALE: 1/8" = 1'-0"  
JOB NUMBER:  
PLOT DATE: 11/9/2010  
FILENAME:


FA - 1 OF 2

 FIRE ALARM PLAN- MAIN LEVEL  
SCALE 1/8" = 1'-0"

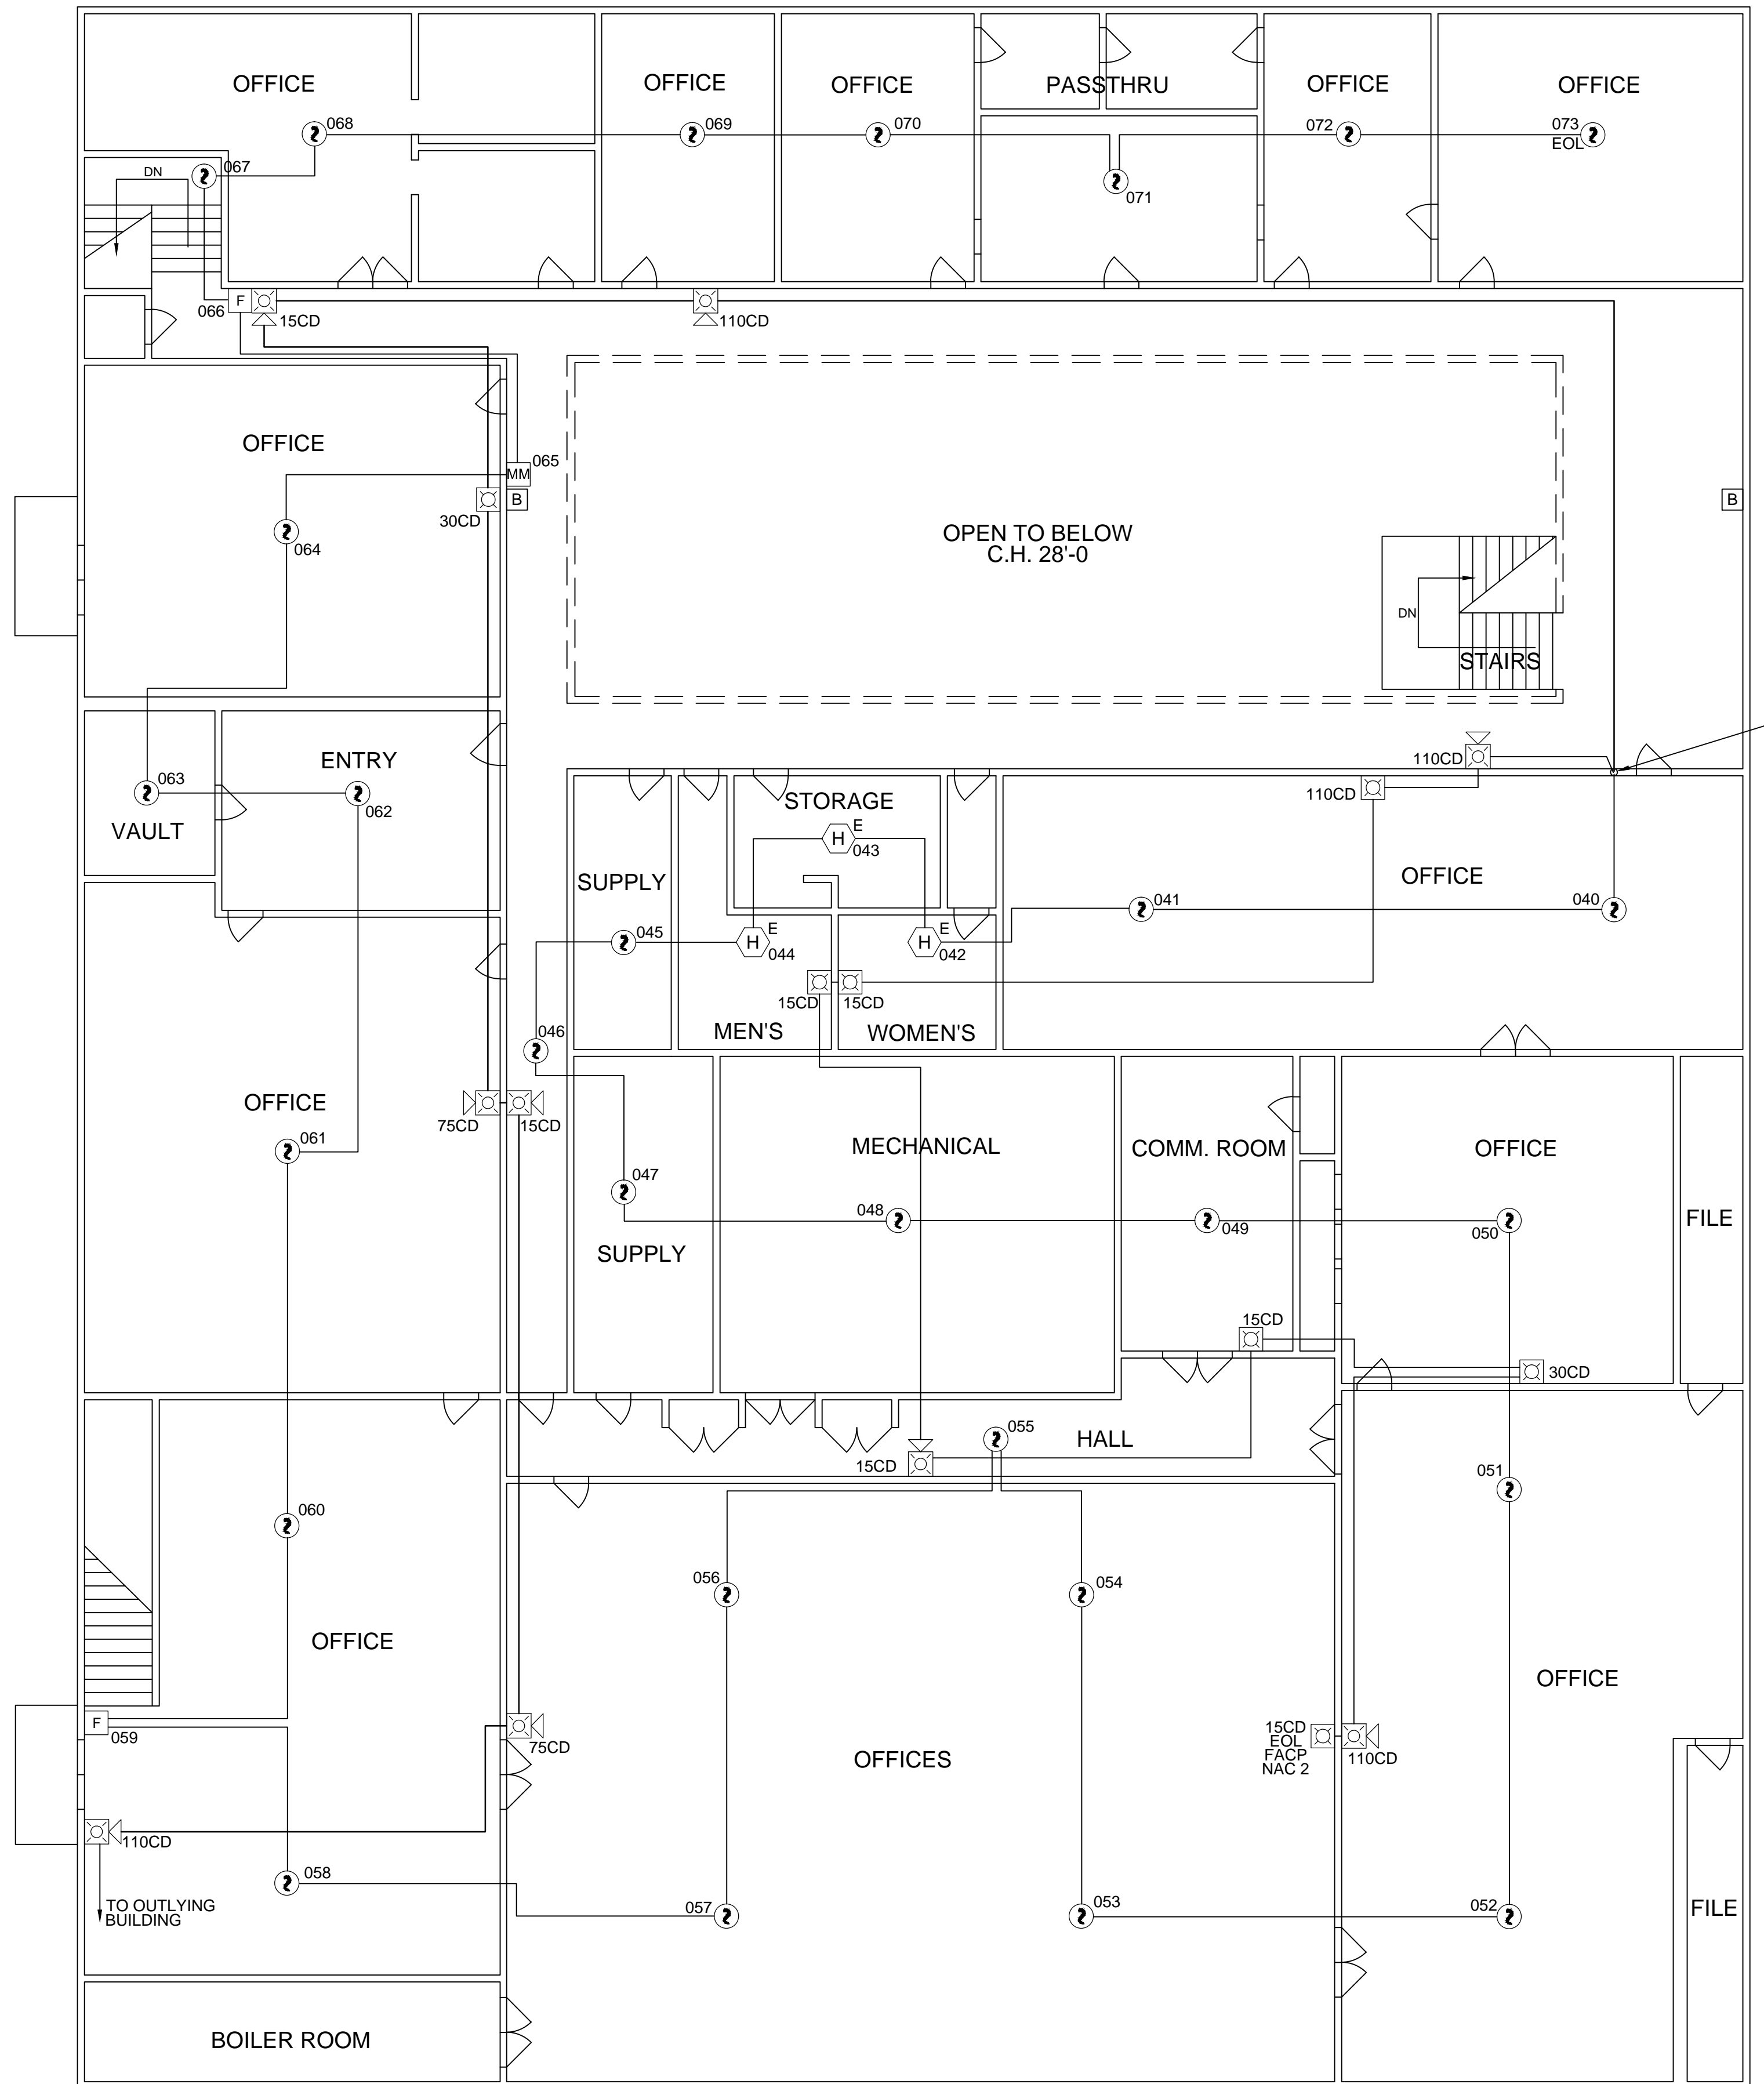

**FIRE ALARM PLAN- UPPER LEVEL**  
 SCALE 1/8" = 1'-0"

Fire Alarm Symbol Legend			
SYMBOL	DESCRIPTION	MODEL NUMBER	MANUFACTURER
SD	Smoke Detector	SD355	ADT
F	Manual Pull Station	ADT-BG-12LX	ADT
110CD	Wall Mount H/S	P2R	SYSTEM SENSOR
15CD	Wall Mount Strobe	SR	SYSTEM SENSOR
FACP	Unimode-200UDLS	Unimode-200UDLS	ADT
ANN	Remote Annunciator	ADT-LCD-80F	ADT
B	Beam Detector	BEAM1224	ADT
H	Heat Detector	H355	ADT
15/75CD	Ceiling Mount Strobe	SCR	SYSTEM SENSOR
95CD	Ceiling Mount H/S	PC2R	SYSTEM SENSOR
MM	Monitor Module	MMF-301	ADT
PS	Power Supply	FCPS-24FS8	ADT

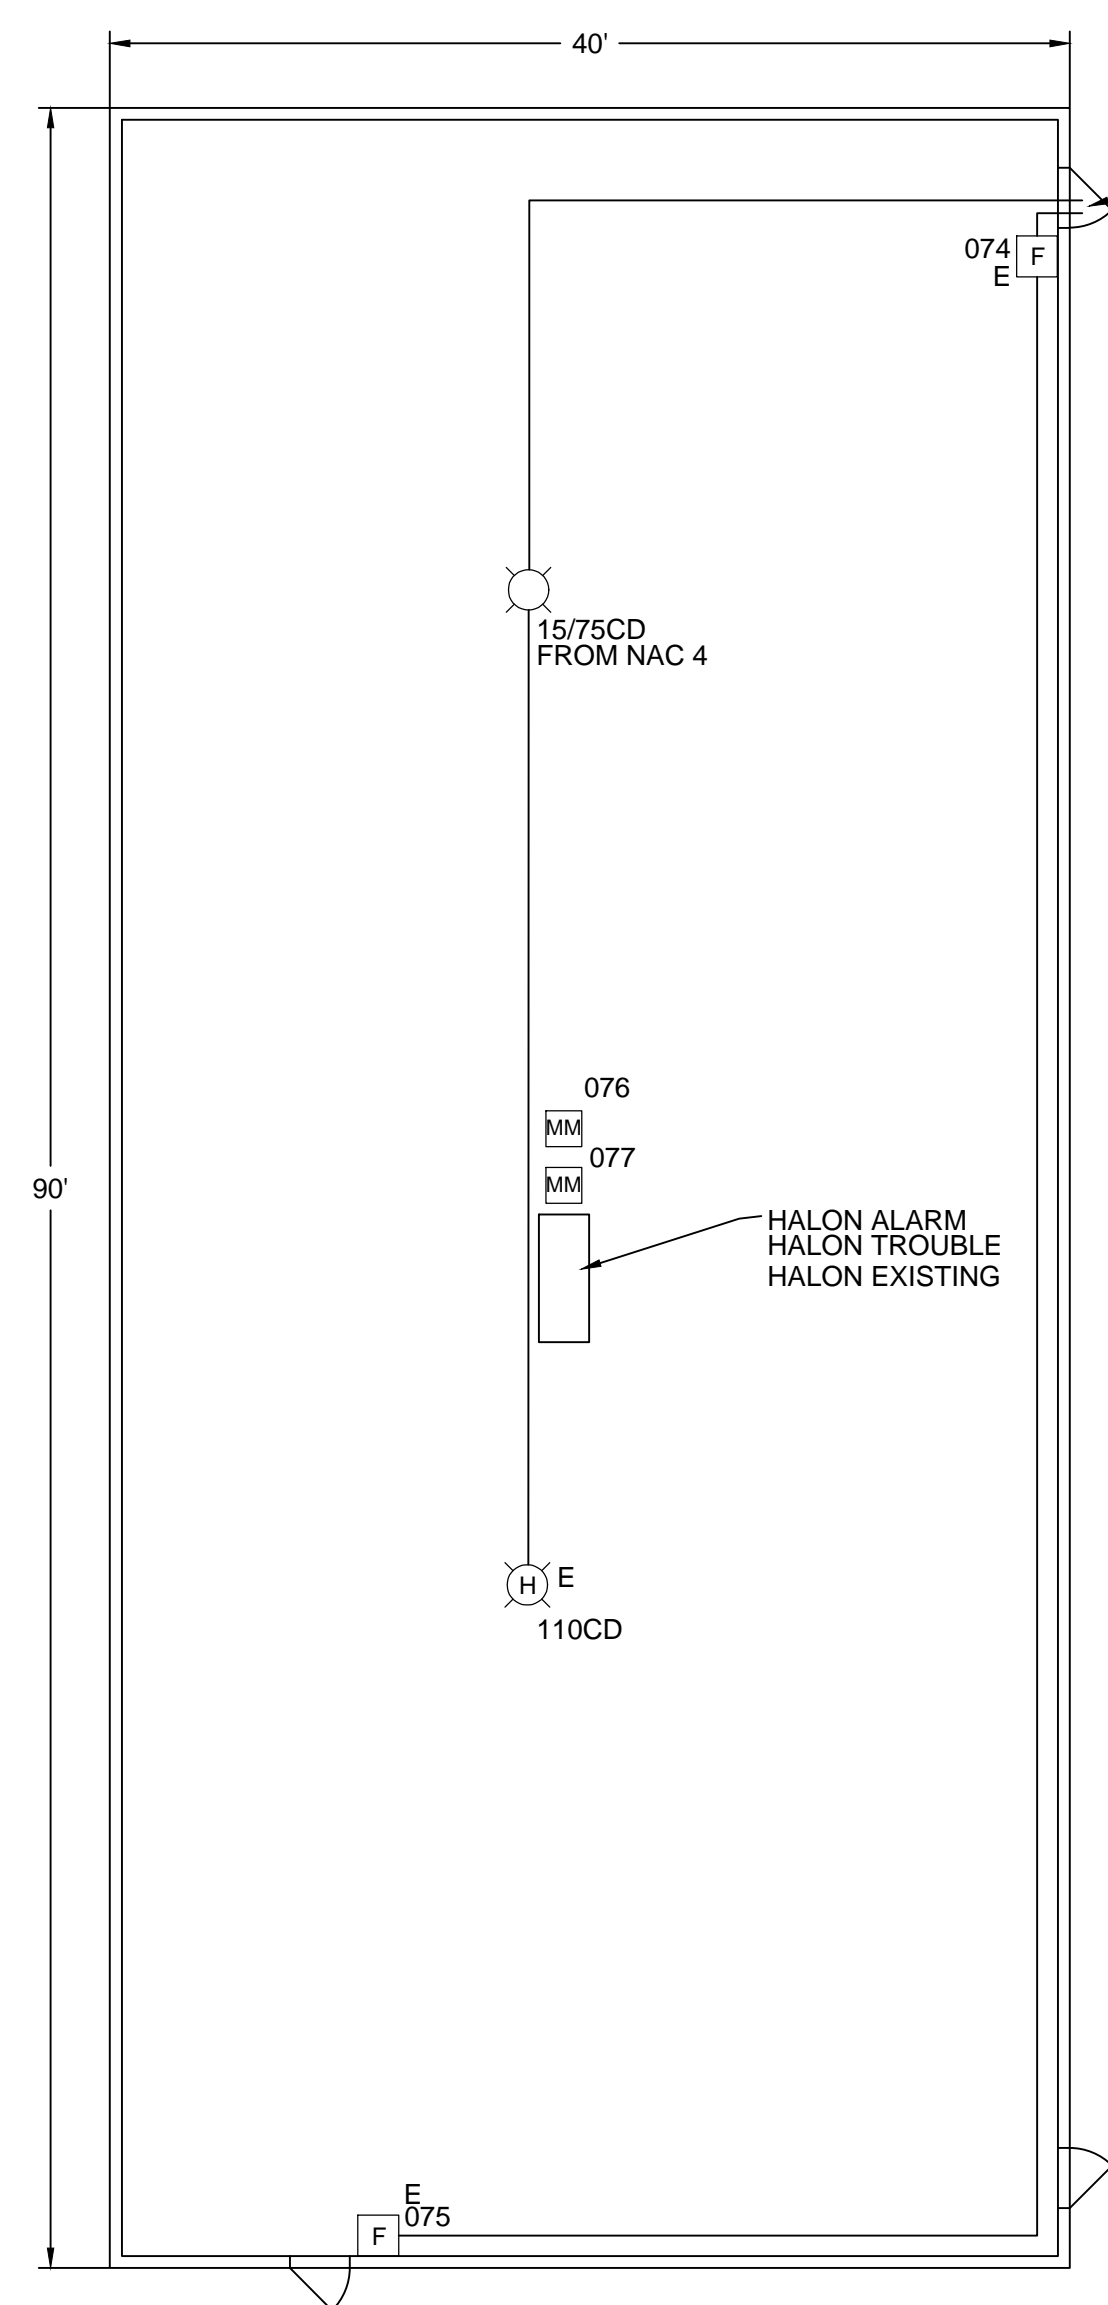

**FIRE ALARM PLAN- OUTLYING BULDING**  
 SCALE 1/8" = 1'-0"

Company Name  
 Physical Address  
 City, State, Zip

No#	Revision Description	Date
1	Fire Alarm System Submittal	11/11/10
x		
x		
x		

Business Name  
 Physical Address  
 City, State, Zip

**IMM**  
 INTERMOUNTAIN MARKETING INC.  
*Representing The Manufacturer*  
 CAD Solutions  
 455 Kokopelli Blvd, Suite D  
 Fruita, CO 81521  
 Telephone: (970) 639-8035  
 www.IMMrep.com

ENGRD BY:  
 DRAWN BY: VJH  
 SCALE: 1/8" = 1'-0  
 JOB NUMBER:  
 PLOT DATE: 11/11/2010  
 FILENAME: